

JUNE 28, 2010

**MALLARD CROSSING**

1548 NERGE  
ELK GROVE VILLAGE, IL 60007  
SQUARE FOOTAGE: 1,200

**EXISTING CONSTRUCTION**

FRONT: ALUM. STOREFRONT ASSEMBLY  
SIDES: 1 HR. GYP. BD. DEMISING WALL  
REAR: 1 HR. GYP. BD. DEMISING WALL


 
 


 


 




 



SALES/HALL:  
2x4 RECESSED  
FLUORESCENT FIXTURES  
2x4 CEILING TILE & GRID  
CEILING FANS  
80 GAL. ELEC. WATER HTR  
FINISHES:  
WALL PAPER, VINYL BASE PAINT

TOILET (NON-ADA):  
2x4 RECESSED  
FLUORESCENT FIXTURES  
2x4 CEILING TILE & GRID  
LAVATORY W/BASE CABINET  
WATER CLOSET  
EXHAUST FAN  
FINISHES:  
PAINT & VINYL BASE


 
ELECTRICAL  
200A 120/208V, 3 $\phi$   
4W 42 BRKR PANEL

WATER SERVICE - 1"  $\phi$

**LEGEND**


	FLUORESCENT LIGHT FIXTURE		TRACK LIGHTS
	FLUORESCENT STRIP FIXTURE		DOWNLIGHT FIXTURE
	BATTERY PACK EMERGENCY FIXTURE		DATA JACK
	EXIT SIGN		TELEPHONE JACK
	TOILET EXHAUST FAN		TELE/DATA JACK
	OUTLETS		F.A. DEVICES
	FIRE EXTINGUISHER		SPRINKLER HEAD
	DIFFUSER / REGISTER		THERMOSTAT
			POWER PANEL

GRAPHIC SCALE

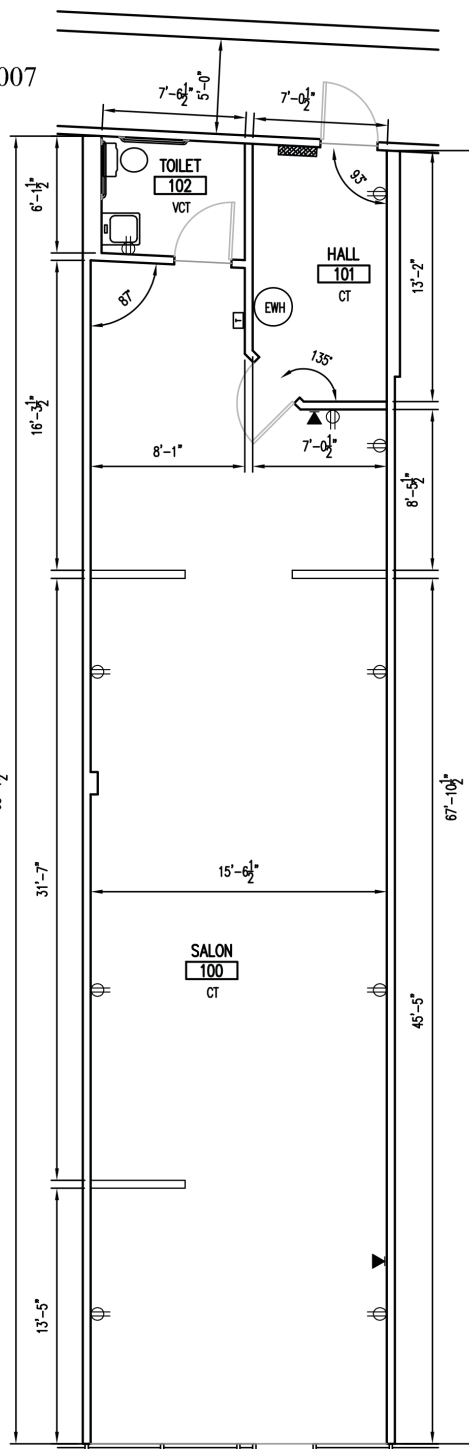

**FLOOR PLAN**

SCALE: 1/8" = 1'-0"

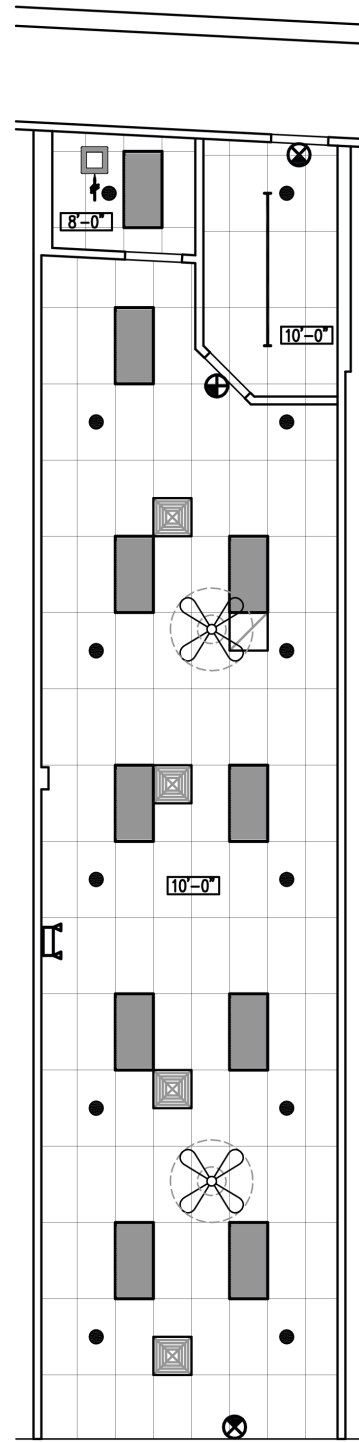

**CEILING PLAN**

SCALE: 1/8" = 1'-0"