


CEILING PLAN
SCALE: 3/32" = 1'-0"

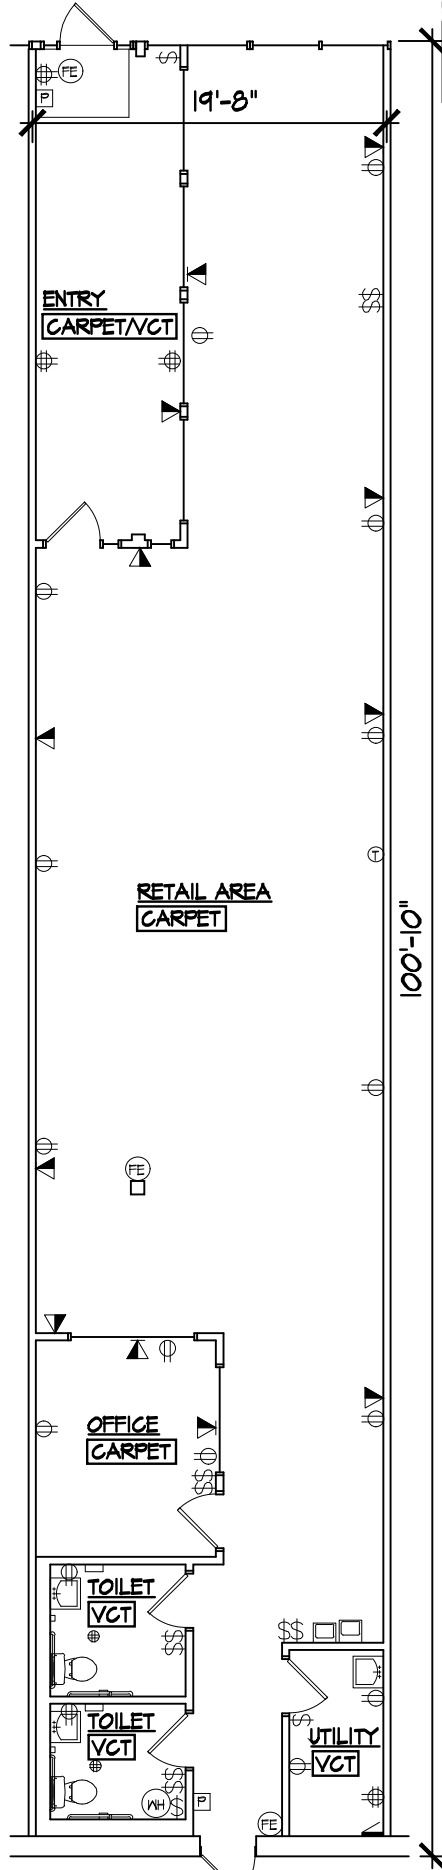

FLOOR PLAN
SCALE: 3/32" = 1'-0"

LOCATION

7511 #166 LEMONT RD.,
DARIEN, IL. 60561
GROSS SQUARE FOOTAGE : 1,986

EXISTING CONSTRUCTION

FRONT / SIDE / REAR :
ALUM. STOREFRONT ASSEMBLY
GYF. BD. ON METAL FURRING
OVER MASONRY

SIDE :
GYF. BD. DEMISING WALLS.

RETAIL AREA :
OUTLETS (MISC. LOCATIONS)
2x4 LIGHT FIXTURES
2x4 LAY-IN CEILING TILE & GRID
WALL FINISH: PAINT W/ VINYL BASE


OFFICE
OUTLETS (MISC. LOCATIONS)
2x4 LAY-IN LIGHT FIXTURES
2x4 LAY-IN CEILING TILE & GRID
WALL FINISH: PAINT W/ VINYL BASE

TOILETS
OUTLETS (MISC. LOCATIONS)
2x4 LAY-IN LIGHT FIXTURES
2x4 LAY-IN CEILING TILE & GRID
WALL FINISH: PAINT W/ VINYL BASE

UTILITY AREA :
OUTLETS (MISC. LOCATIONS)
2x4 LAY-IN LIGHT FIXTURES
2x4 LAY-IN CEILING TILE & GRID
WALL FINISH: PAINT W/ VINYL BASE
150A PANEL : 240V, 3Ø, 4W,
42 BRKR PANEL W/ 150A DISC.

LEGEND

	FIRE ALARM PULL STATION		1x4 LINEAR LIGHT FIXTURE
	SPEAKER		HEAT / SMOKE DETECTOR
	TRACK LIGHT		SECURITY CAMERA
	TOILET EXH. FAN		THERMOSTAT
	2x4 FLUORESCENT LIGHT FIXTURE		POWER PANEL
	PENDANT LIGHT FIXTURE		DIFFUSER / REGISTER
	EXIT SIGN		AUDIO / VISUAL ALARM SYSTEM
	BATTERY PACK EMERGENCY FIXTURE		SPRINKLER

 

NOVEMBER 9, 2017

LEASING INQUIRIES
PHONE: 877.206.5656
EMAIL: LEASING@IRCRETAILCENTERS.COM
IRCRETAILCENTERS.COM