

LOCATION
 1424 S. MILWAUKEE AVE.,
 LIBERTYVILLE, IL. 60048
 GROSS SQUARE FOOTAGE : 1,600

EXISTING CONSTRUCTION

FRONT / SIDE / REAR :
 ALUM. STOREFRONT ASSEMBLY
 GYP. BD. ON METAL FURRING
 OVER MASONRY

SIDE :
 GYP. BD. DEMISING WALLS.


RETAIL AREA :
 OUTLETS (MISC. LOCATIONS)
 1x4 AND RECESSED INCAND. LIGHT FIXTURES
 2x4 LAY-IN CEILING TILE & GRID
 WALL FINISH: PAINT W/ VINYL BASE

OFFICE
 OUTLETS (MISC. LOCATIONS)
 1x4 LAY-IN LIGHT FIXTURES
 2x4 LAY-IN CEILING TILE & GRID
 WALL FINISH: PAINT W/ VINYL BASE

TOILETS
 OUTLETS (MISC. LOCATIONS)
 WALL MOUNTED LIGHT FIXTURE
 2x4 LAY-IN CEILING TILE & GRID
 WALL FINISH: PAINT W/ VINYL BASE


UTILITY AREA :
 OUTLETS (MISC. LOCATIONS)
 2x4 LAY-IN LIGHT FIXTURES
 2x4 LAY-IN CEILING TILE & GRID
 WALL FINISH: PAINT W/ VINYL BASE
 200A PANEL : 240V, 3Φ, 4W,
 42 BRKR PANEL W/ 150A DISC.

@ the front its
 B/deck 16' - 10" and B/Joist 14' - 6"
 @ the rear its
 B/deck 17' - 1" and B/Joist 14' - 8"
 updated 06-19-18

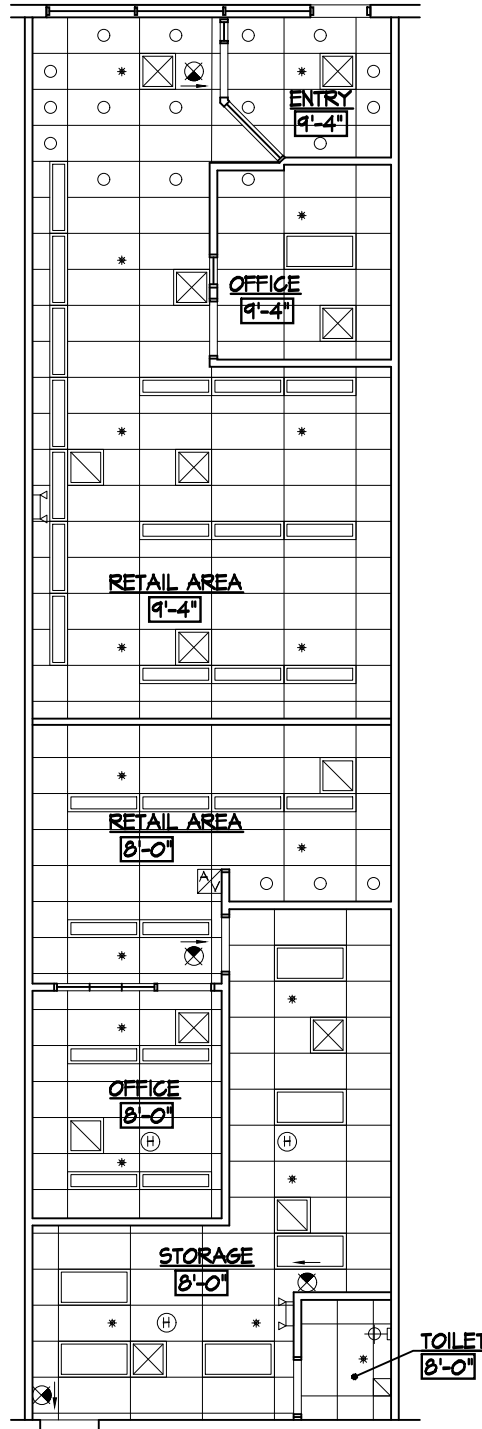

CEILING PLAN

SCALE: 3/32" = 1'-0"

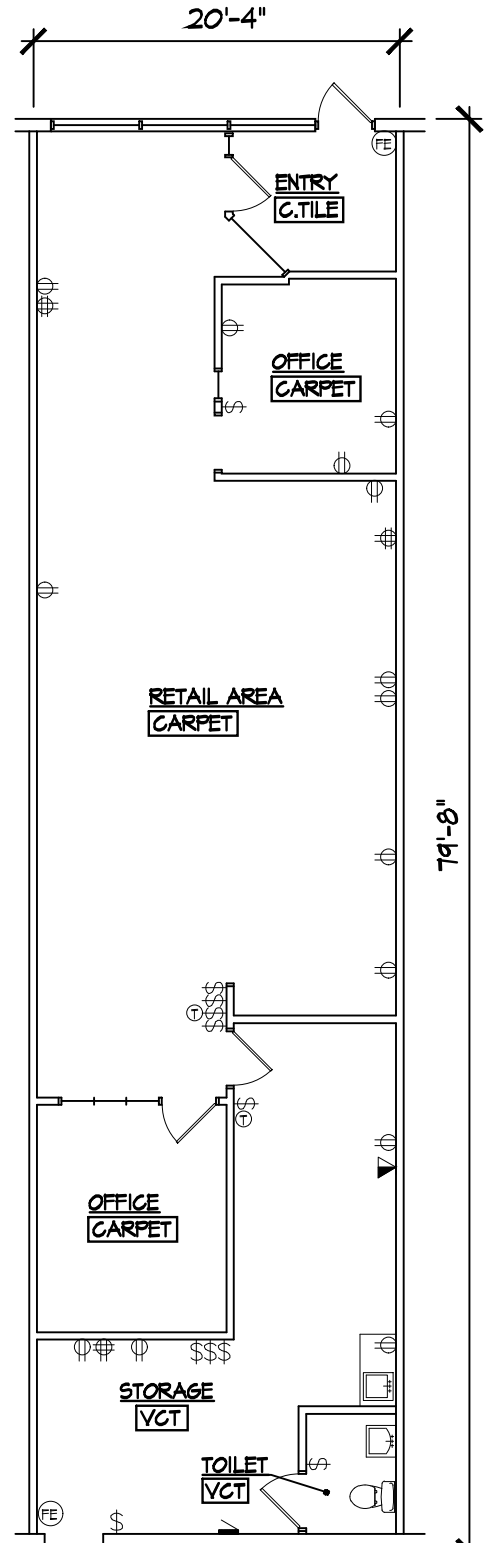

FLOOR PLAN

SCALE: 3/32" = 1'-0"



LEGEND

	FIRE ALARM PULL STATION		1x4 LINEAR LIGHT FIXTURE
	SPEAKER		HEAT / SMOKE DETECTOR
	TRACK LIGHT		SECURITY CAMERA
	TOILET EXH. FAN		THERMOSTAT
	2x4 FLUORESCENT LIGHT FIXTURE		POWER PANEL
	PENDANT LIGHT FIXTURE		DIFFUSER / REGISTER
	EXIT SIGN		AUDIO / VISUAL ALARM SYSTEM
	BATTERY PACK EMERGENCY FIXTURE		SPRINKLER

GRAPHIC SCALE

 NOVEMBER 17, 2017