

LOCATION

1322 S. MILWAUKEE AVE,
LIBERTYVILLE, IL 60048
GROSS S.F. : 1,600

EXISTING CONSTRUCTION

FRONT WALL
ALUM. STOREFRONT ASSEMBLY

REAR WALL
CMU WALL


SIDE WALLS
GYP. BD. DEMISING WALLS

RECEPTION AND HAIR SERVICE AREA
OUTLETS (MISC. LOCATIONS)
2x4 LIGHT FIXTURES
EXPOSED CEILING
WALL FINISH: PAINT

DRESSING ROOMS, OFFICES AND UTILITIES
OUTLETS (MISC. LOCATIONS)
2x4 LIGHT FIXTURES
EXPOSED CEILING
WALL FINISH: PAINT W/ WOOD WAINSCOT


STORAGE
OUTLETS (MISC. LOCATIONS)
2x4 LIGHT FIXTURES
2x4 LAY-IN CEILING TILE & GRID
WALL FINISH: PAINT W/ WOOD WAINSCOT

TOILET
OUTLETS (MISC. LOCATIONS)
FAN AND LIGHT FIXTURE
GYP. BD. CEILING
WALL FINISH: PAINT W/ WOOD WAINSCOT

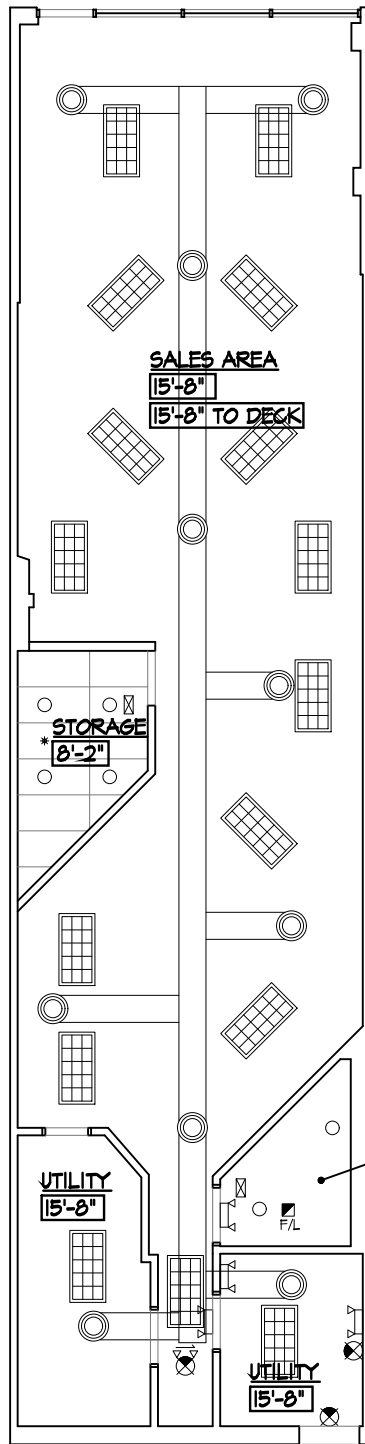

CEILING PLAN

SCALE: 3/32" = 1'-0"

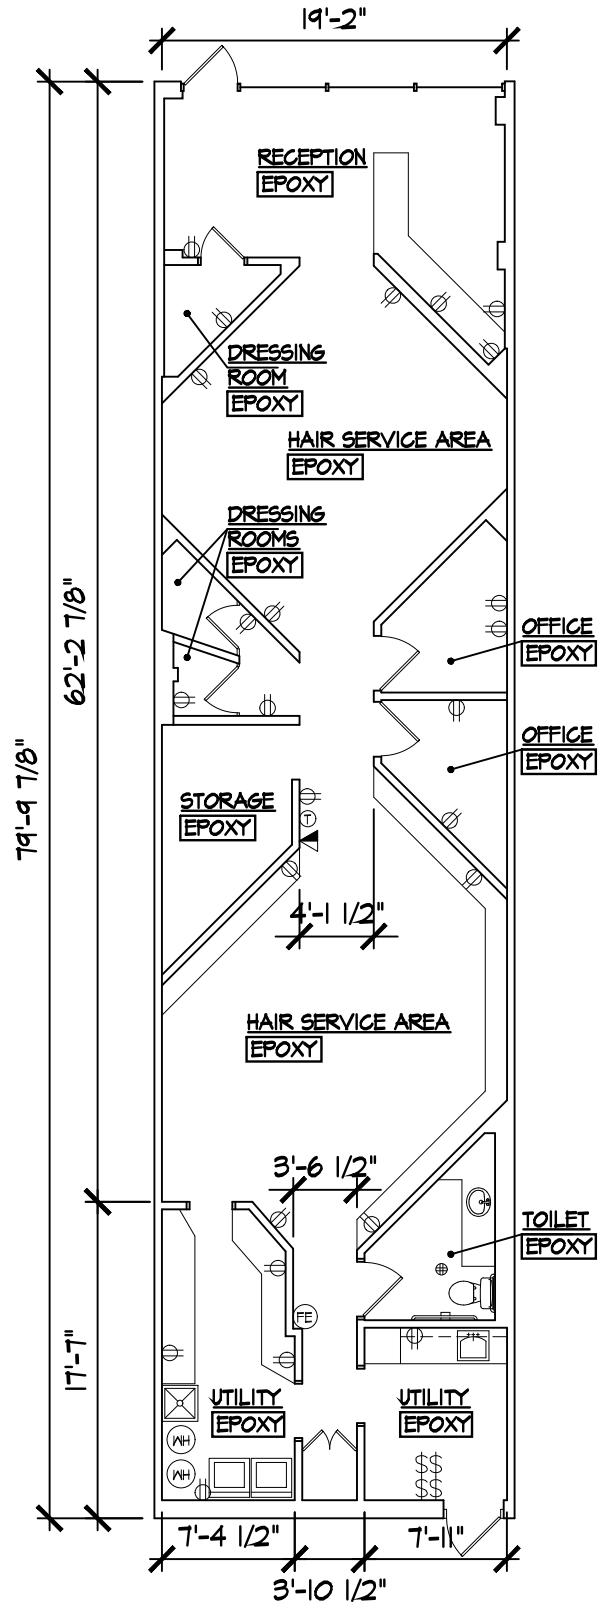


FLOOR PLAN

SCALE: 3/32" = 1'-0"



| LEGEND | | | |
|--------|--------------------------------|--|-----------------------------|
| | WALL OUTLET | | FLOOR/CLS OUTLET |
| | LIGHT SWITCH | | FLOOR DRAIN |
| | FIRE ALARM PULL STATION | | 6x4 LINEAR LIGHT FIXTURE |
| | SPEAKER | | HEAT / SMOKE DETECTOR |
| | TRACK LIGHT | | SECURITY CAMERA |
| | TOILET EXH. FAN | | THERMOSTAT |
| | 2x4 FLUORESCENT LIGHT FIXTURE | | POWER PANEL |
| | PENDANT LIGHT FIXTURE | | DIFFUSER / REGISTER |
| | EXIT SIGN | | AUDIO / VISUAL ALARM SYSTEM |
| | BATTERY PACK EMERGENCY FIXTURE | | SPRINKLER |
| | FIRE EXTINGUISHER | | TIMER |

 

NOVEMBER 21, 2018

LEASING INQUIRIES
PHONE: 877.206.5656
EMAIL: LEASING@IRCETAILCENTERS.COM
IRCETAILCENTERS.COM