

**LOCATION**

19985 S. LaGrange ROAD, UNIT 004  
 FRANKFORT, IL 60423  
 ± 1,440 SQ-FT

**EXISTING CONSTRUCTION**

**FRONT WALL**  
 ALUM. STOREFRONT ASSEMBLY

**REAR WALL**  
 CMU WALL

**SIDE WALLS**  
 GYP. BD. DEMISING WALLS

**SALES AREA**  
 OUTLETS (MISC. LOCATIONS)  
 PENDANT LIGHT FIXTURES  
 2x4 LIGHTS FIXTURES  
 2x2 LAY-IN CEILING TILE & GRID  
 WALL FINISH: PAINT W/ VINYL BASE  
 200A PANEL : 240V, 3Ø, 4W


**KITCHEN**  
 OUTLETS (MISC. LOCATIONS)  
 2x4 LIGHTS FIXTURES  
 2x2 LAY-IN CEILING TILE & GRID  
 WALL FINISH: FRP W/ VINYL BASE

**TOILETS**  
 OUTLETS (MISC. LOCATIONS)  
 FAN AND LIGHT FIXTURE  
 2x2 LAY-IN CEILING TILE & GRID  
 WALL FINISH: PAINT W/ VINYL BASE


**LEGEND**

	WALL OUTLET		FLOOR/CLS OUTLET
	LIGHT SWITCH		FLOOR DRAIN
	FIRE ALARM PULL STATION		6x4 LINEAR LIGHT FIXTURE
	SPEAKER		HEAT / SMOKE DETECTOR
	OCCUPANCY SENSOR		SECURITY CAMERA
	TOILET EXH. FAN		THERMOSTAT
	2x4 FLUORESCENT LIGHT FIXTURE		POWER PANEL
	PENDANT LIGHT FIXTURE		DIFFUSER / REGISTER
	EXIT SIGN		AUDIO / VISUAL ALARM SYSTEM
	BATTERY PACK EMERGENCY FIXTURE		SPRINKLER
	FIRE EXTINGUISHER		TIMER

GRAPHIC SCALE  
  
 APRIL 23, 2019

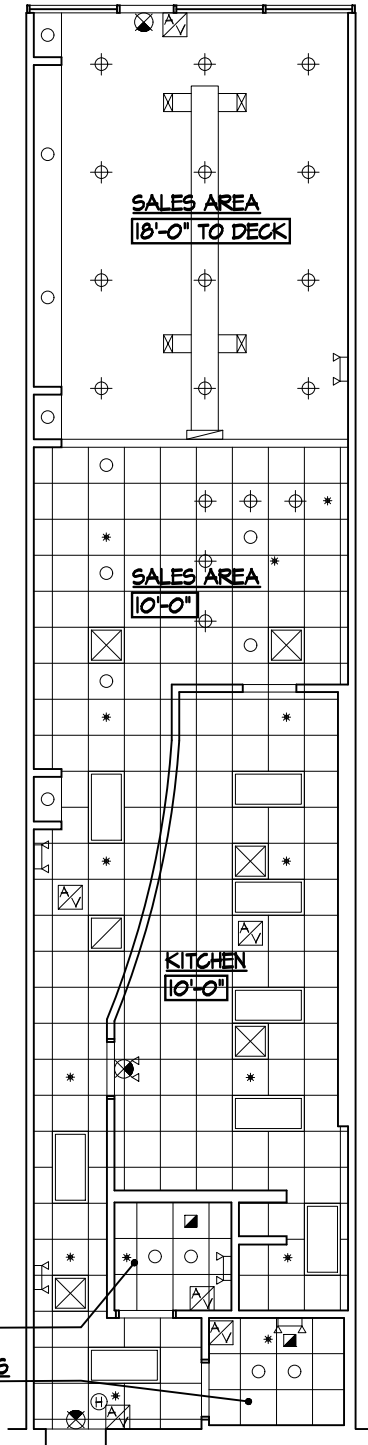

**CEILING PLAN**  
 SCALE: 3/32" = 1'-0"

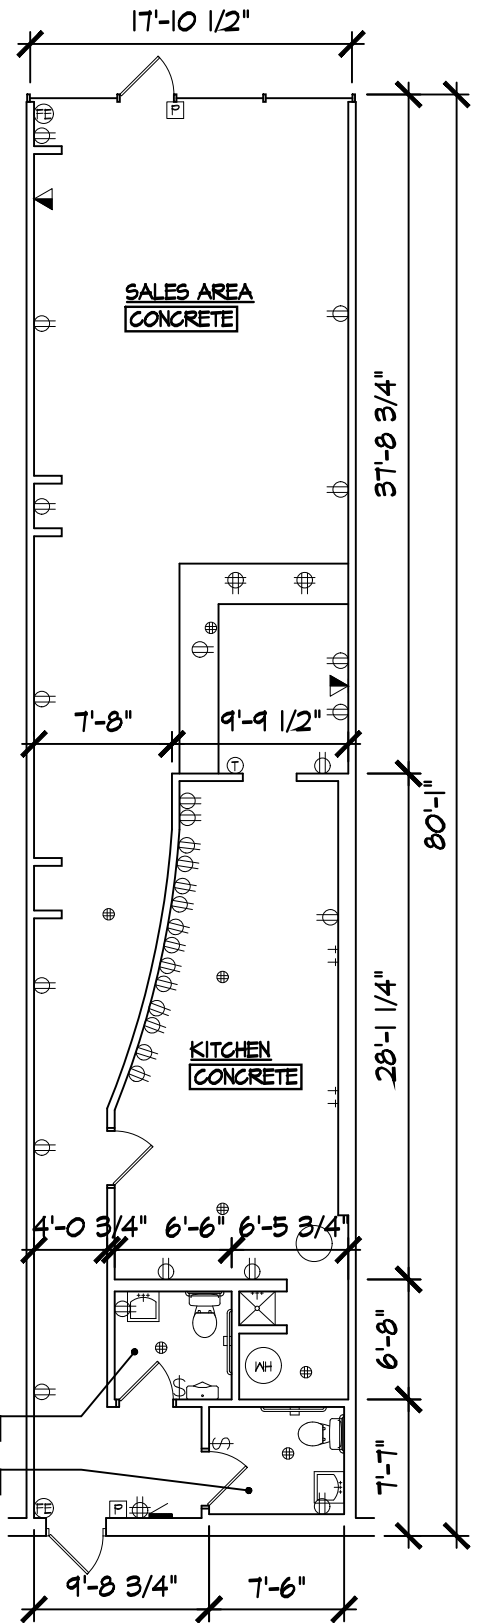

**FLOOR PLAN**  
 SCALE: 3/32" = 1'-0"

LEASING INQUIRIES  
 PHONE: 877.206.5656  
 EMAIL: LEASING@IRCRETAILCENTERS.COM  
 IRCRETAILCENTERS.COM