
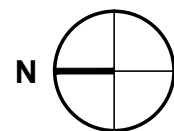


FLOOR PLAN KEY NOTES:

- 1 200A 120/208V ELEC. PANEL
- 2 40 GALLON GAS WATER HEATER
- 3 HW, CW, AND DRAIN STUBS FOR FUTURE PLUMBING SINK/LAVATORY
- 4 CONCRETE LOADING PLATFORM
- 5 MOP SINK & FAUCET
- 6 ALUM. FRAMED STOREFRONT SYSTEM w/ 1" TH. INSULATED CLEAR GLAZING
- 7 LINE OF CANOPY OVERHEAD
- 8 GYPSUM DEMISING WALL
- 9 ASPHALT DRIVE
- 10 CONCRETE SIDEWALK
- 11 CONCRETE CURB
- 12 WATER METER
- 13 FIRE ALARM PANEL

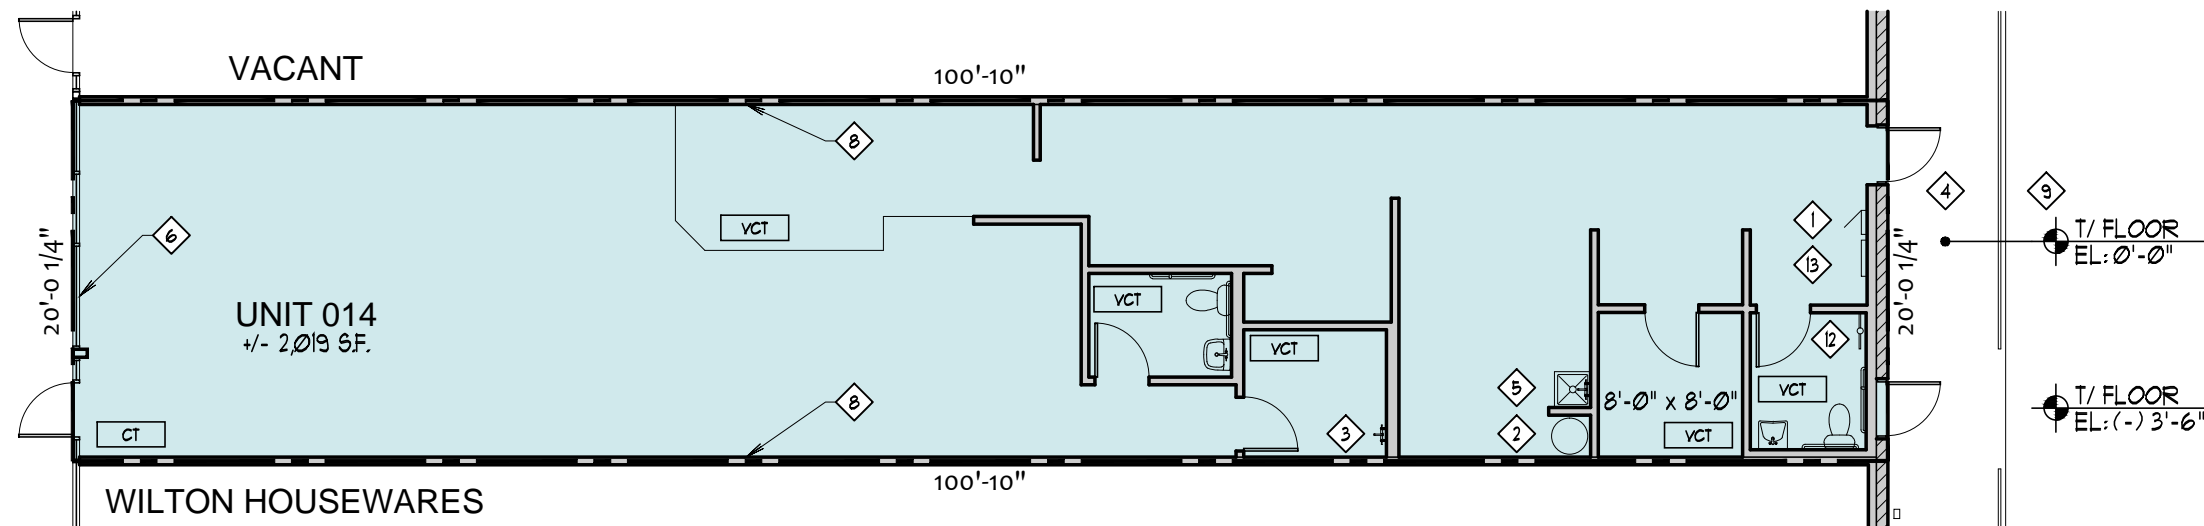

FLOOR PLAN

SCALE: 3/32" = 1'-0"

EXISTING PREMISES ARE FULLY
SPRINKLED